

NO.	DATE	REVISION





MANAGER:	CLAYTON BUECK, P.E.
DESIGN BY:	CHD BY:
CH/CH	CH/CH
DRAMM BY:	CHD BY:
CEB/CH	CEB
FIELDBOOK NO.	DATE OUTLOR
SURV. CHIEF:	R. ORNER

CLIENT
SCHUYLKILL HEADWATERS ASSOCIATION, INC.
 P.O. BOX 1385
 POTTSTOWN, PA 17901
 (570) 385-2122

RETTEW Associates, Inc.
 Union Street Station, 101 East Union Street
 Pottsville, PA 17901
 Phone: (570) 622-8222 • Fax: (570) 622-4260
 Email: rettew@rettew.com Website: www.rettew.com
 Behrman, PA • Camp Hill, PA • Pottsville, PA • York, PA
 Engineers • Planners • Surveyors • Landscape Architects
 Environmental Consultants • IT Consultants

ABANDONED MINE DRAINAGE REMEDIATION
 FOR THE
MACKEYSBURG RESTORATION PROJECT
SCHUYLKILL HEADWATERS ASSOCIATION, INC.
 PROPOSED SITE PLAN
 SCHUYLKILL COUNTY, PA
 CASS TOWNSHIP
 DATE: NOV. 29, 2005
 SHEET NO. 3 OF 6
 DWG. NO. 05-04234-001

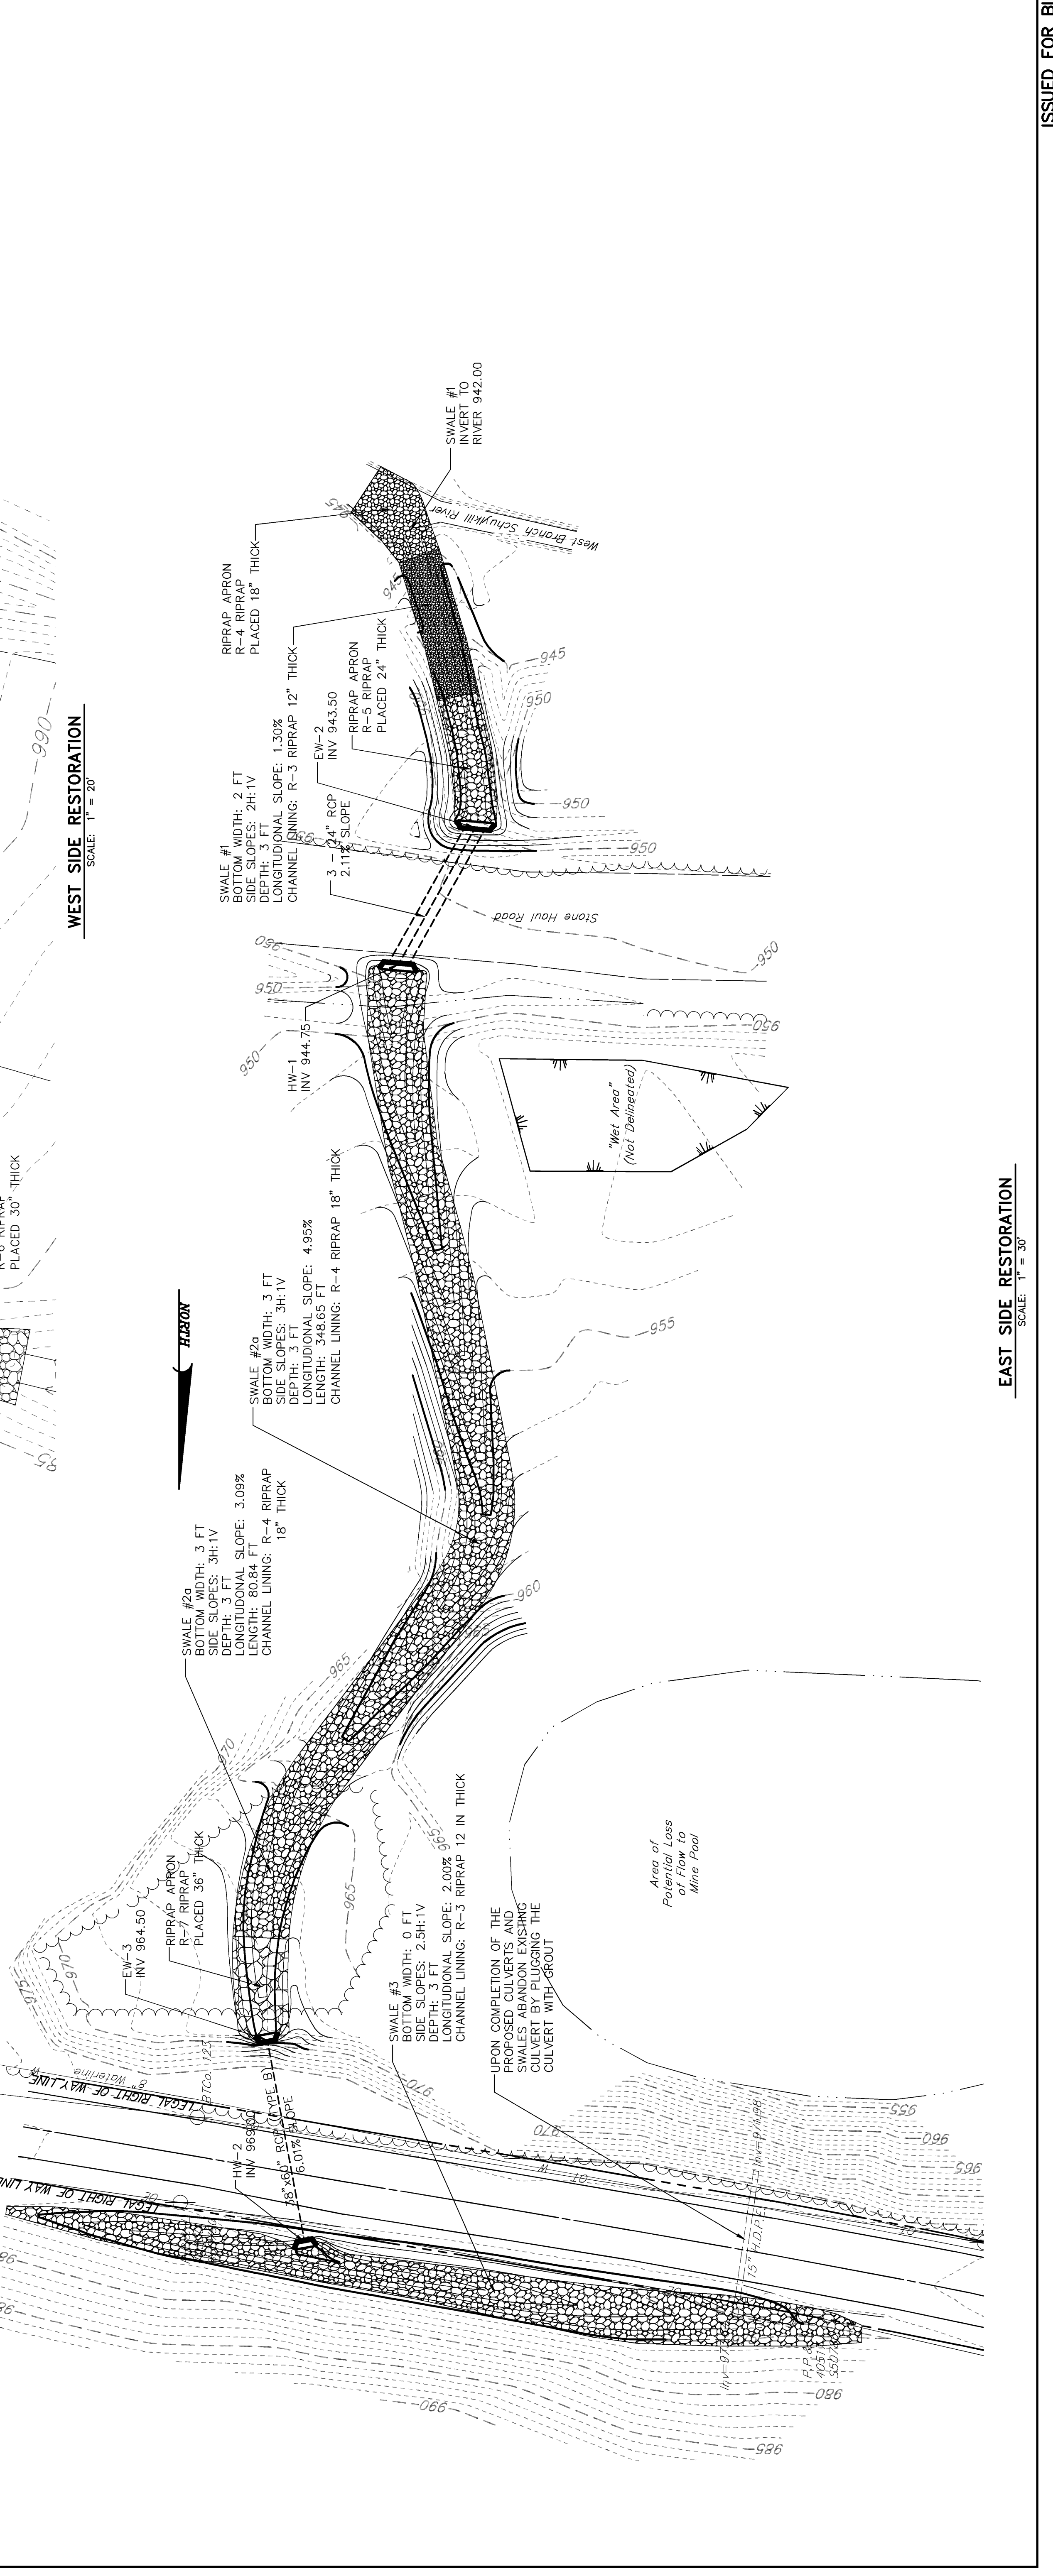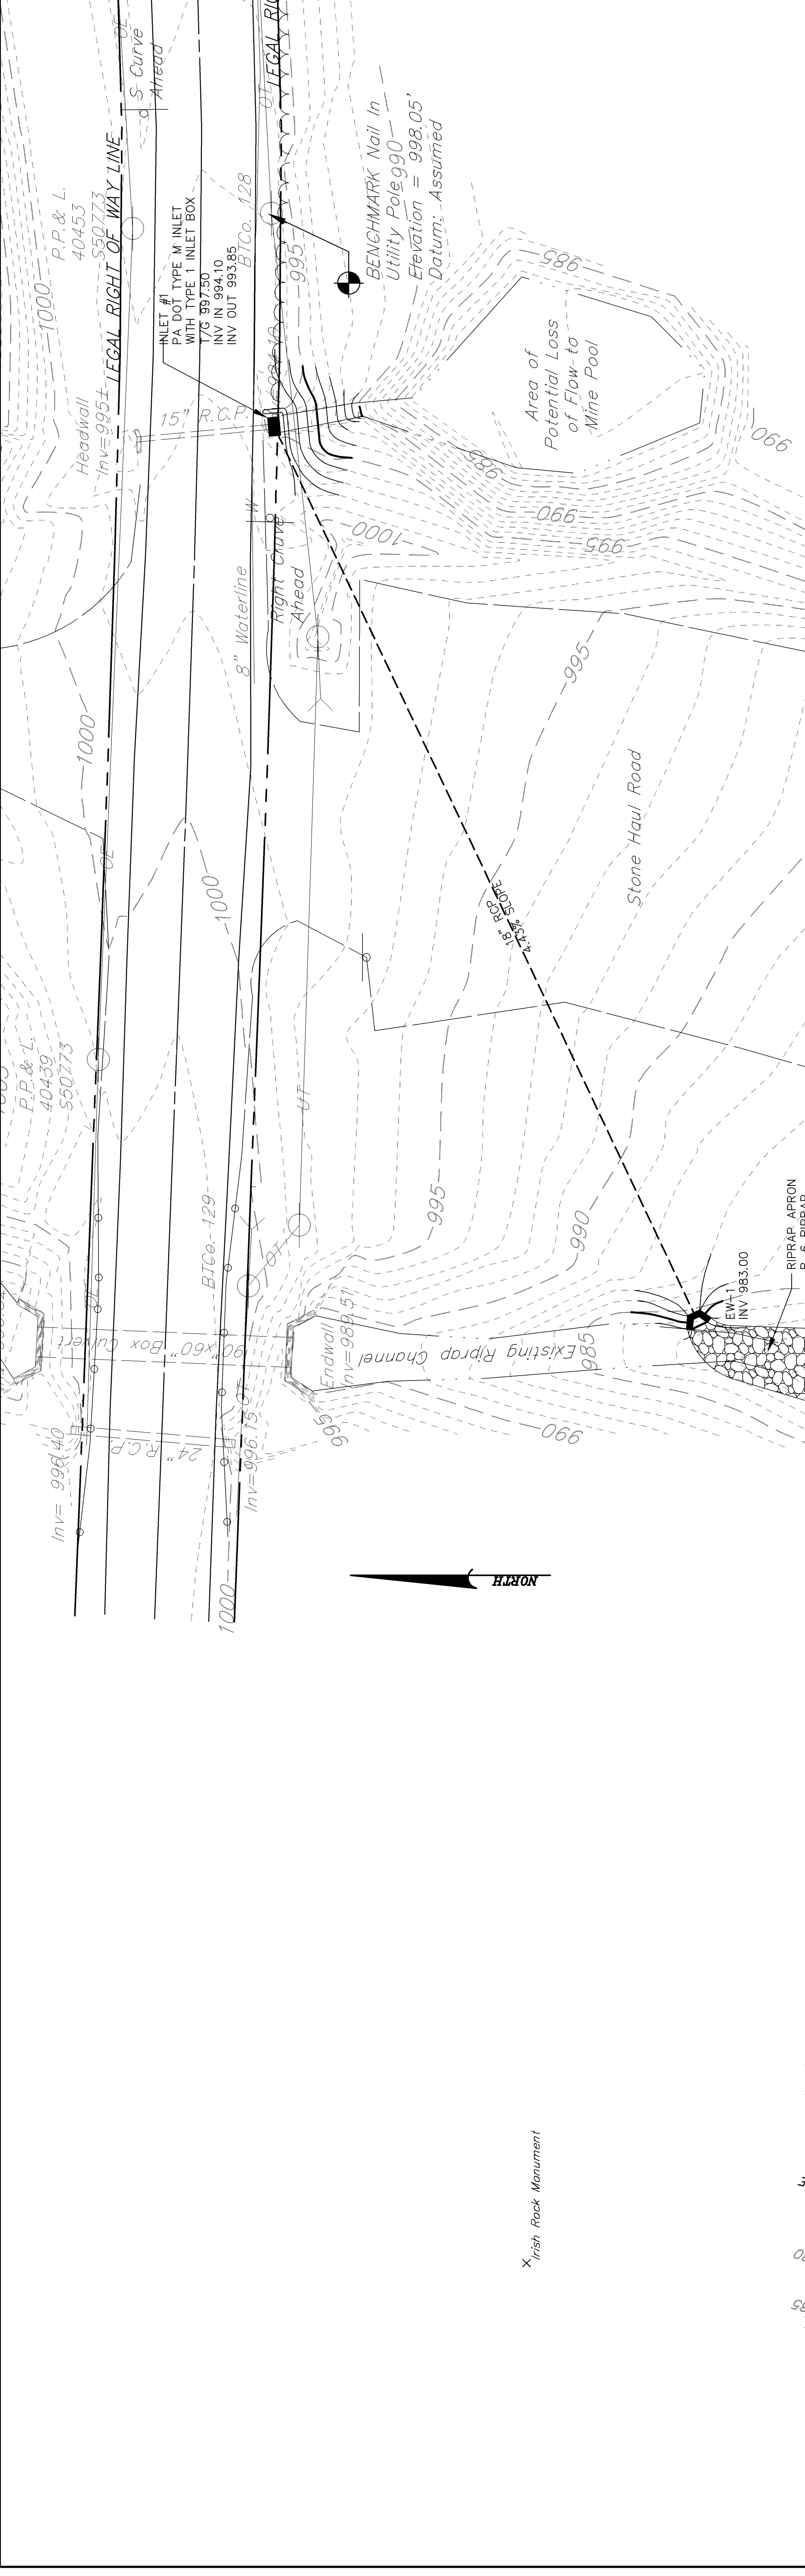

ISSUED FOR BIDDING/CONSTRUCTION