


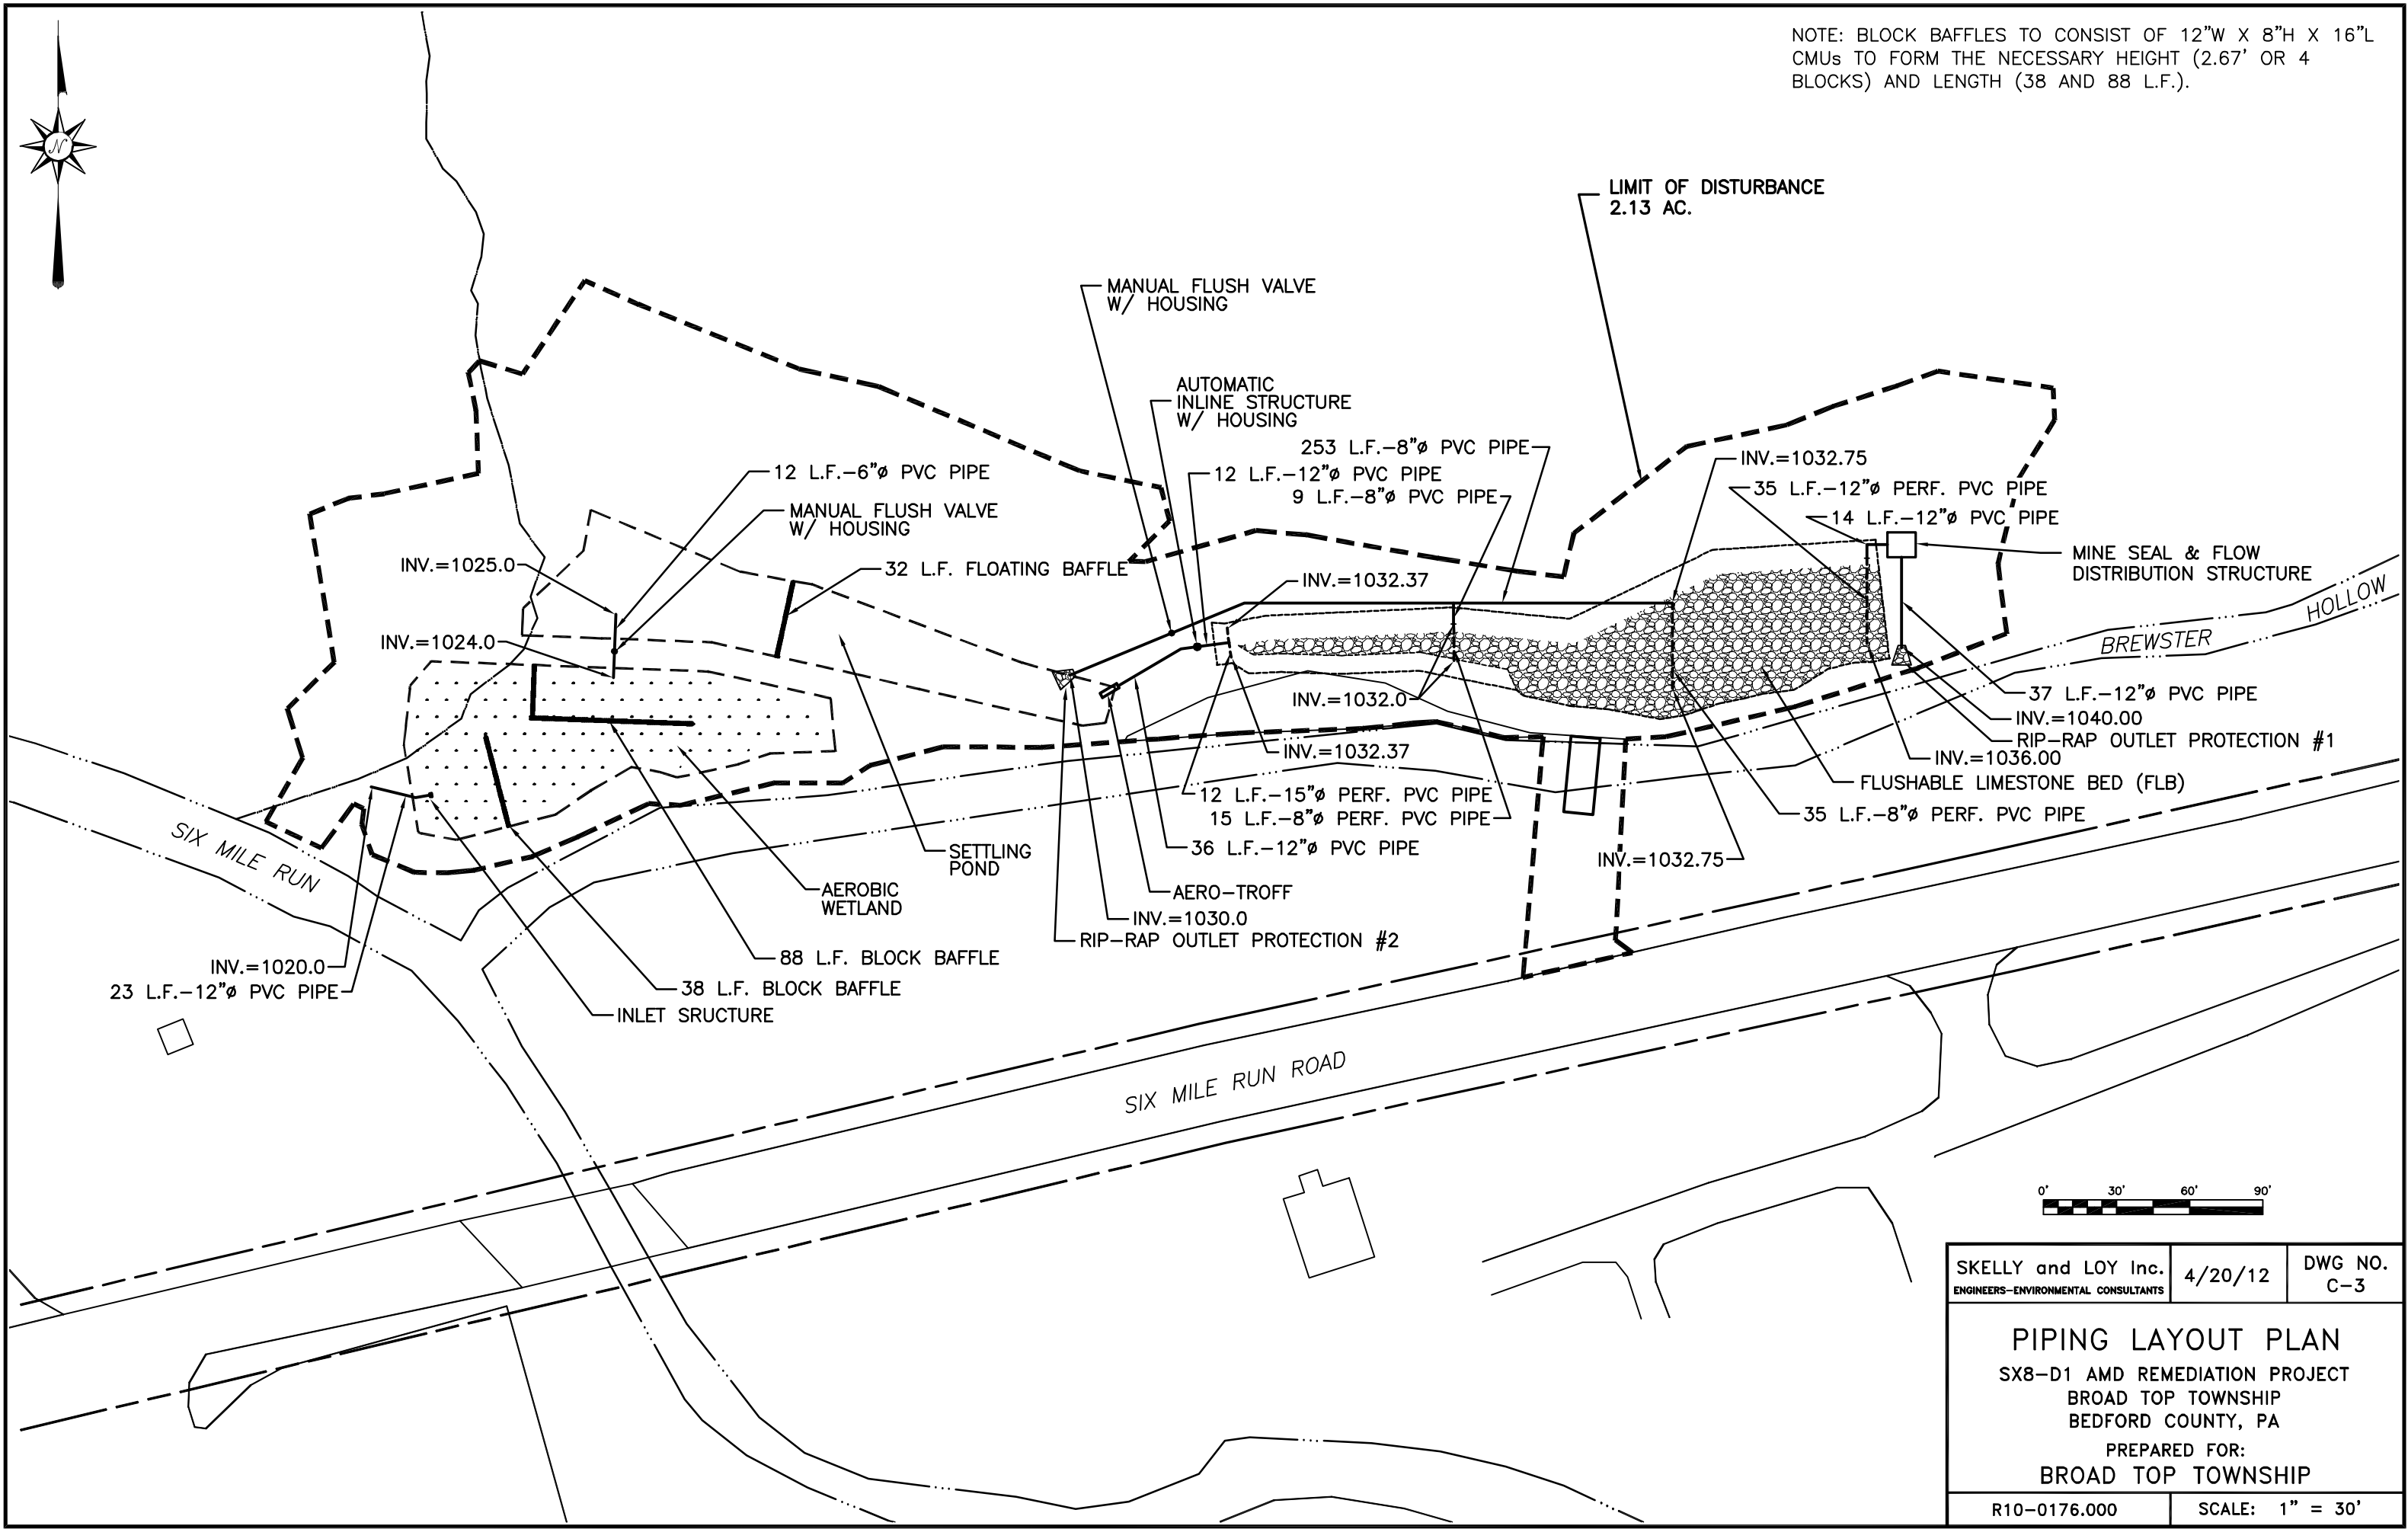

NOTE: BLOCK BAFFLES TO CONSIST OF 12"W X 8"H X 16"L CMUs TO FORM THE NECESSARY HEIGHT (2.67' OR 4 BLOCKS) AND LENGTH (38 AND 88 L.F.).



SKELLY and LOY Inc. ENGINEERS-ENVIRONMENTAL CONSULTANTS	4/20/12	DWG NO. C-3
PIPING LAYOUT PLAN SX8-D1 AMD REMEDIATION PROJECT BROAD TOP TOWNSHIP BEDFORD COUNTY, PA PREPARED FOR: BROAD TOP TOWNSHIP		
R10-0176.000	SCALE: 1" = 30'	